


FRONT ELEVATION (CONT.)  
SCALE: 1/4" = 1'-0"

FRONT ELEVATION  
SCALE: 1/4" = 1'-0"

NOTE: THESE ELEVATIONS ARE TYPICAL FOR THIS TYPE BLDG (TYPE E)

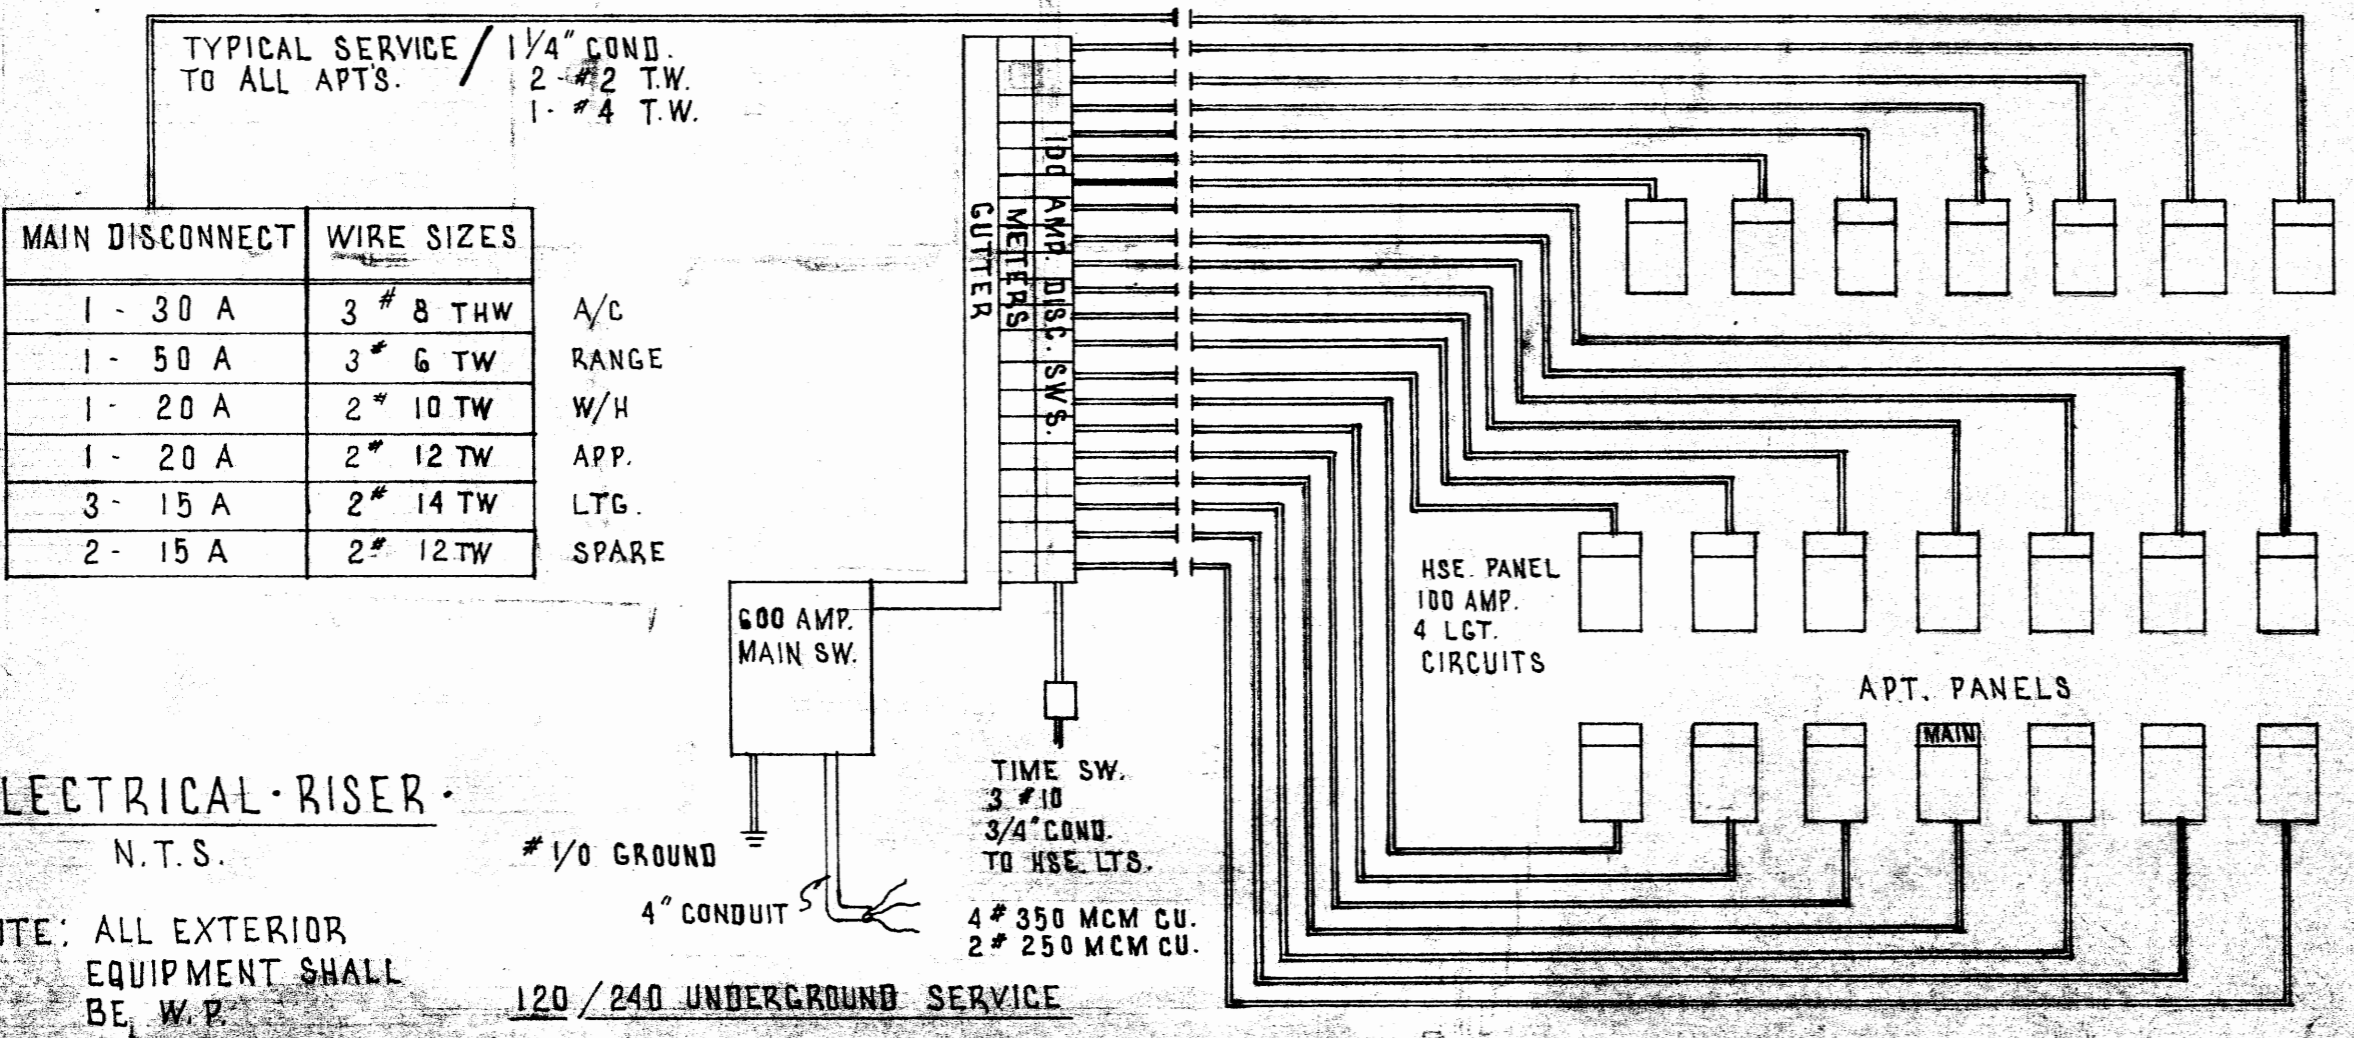

WINDJAMMER - 18 UNIT CONDO BUILDING'S "E" THE BRITISH MERCHANT & CARLISLE CASTLE  
FRONT EXTERIOR ELEVATION AND ELECTRICAL RISER

**COLLINS AND COMPANY**  
consulting engineers

2586 FOREST HILL BOULEVARD • WEST PALM BEACH • FLORIDA 33406

drawing number	212114
of	8
date	12-15-72
scale	1/4" = 1'-0"
designed by	[Signature]
checked by	[Signature]
approved by	[Signature]
date	12-15-72