




ELEVATION D
SCALE: 3/8" = 1'-0"

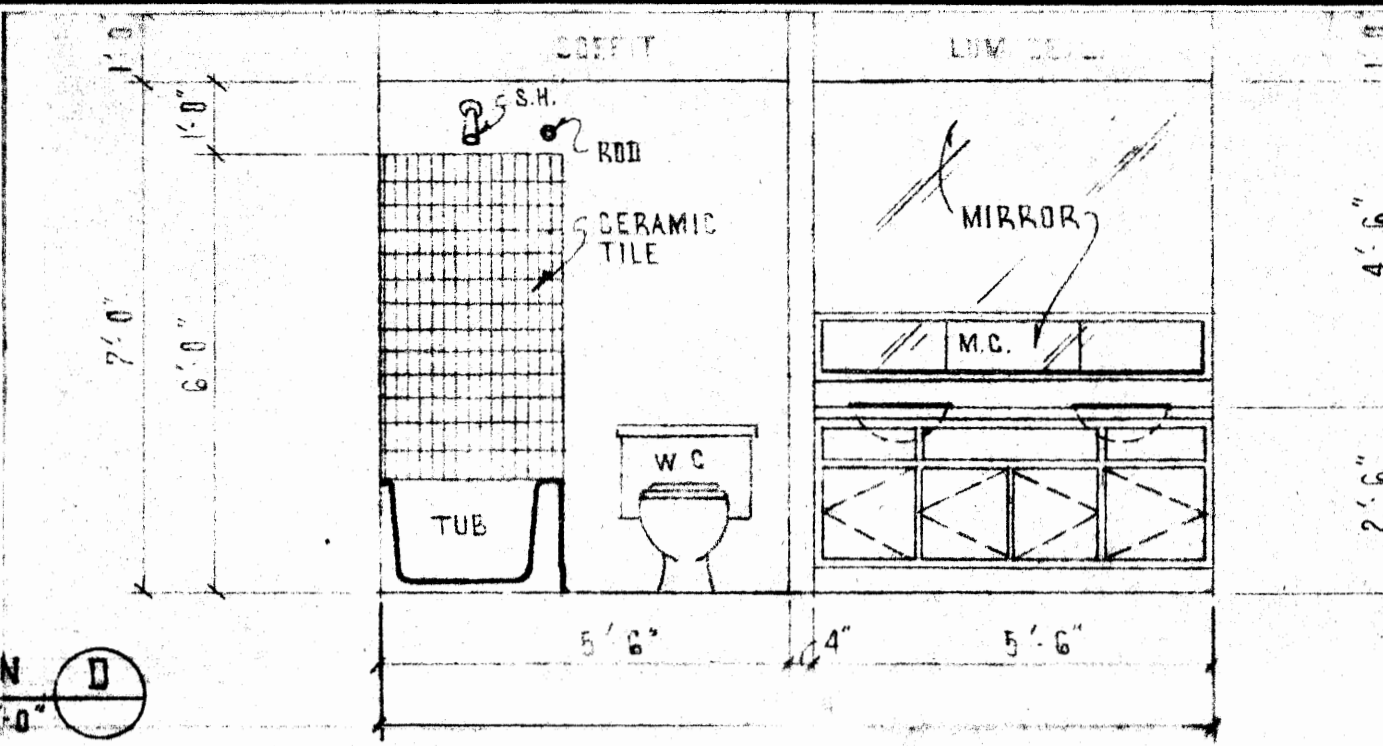

ELEVATION E
SCALE: 3/8" = 1'-0"

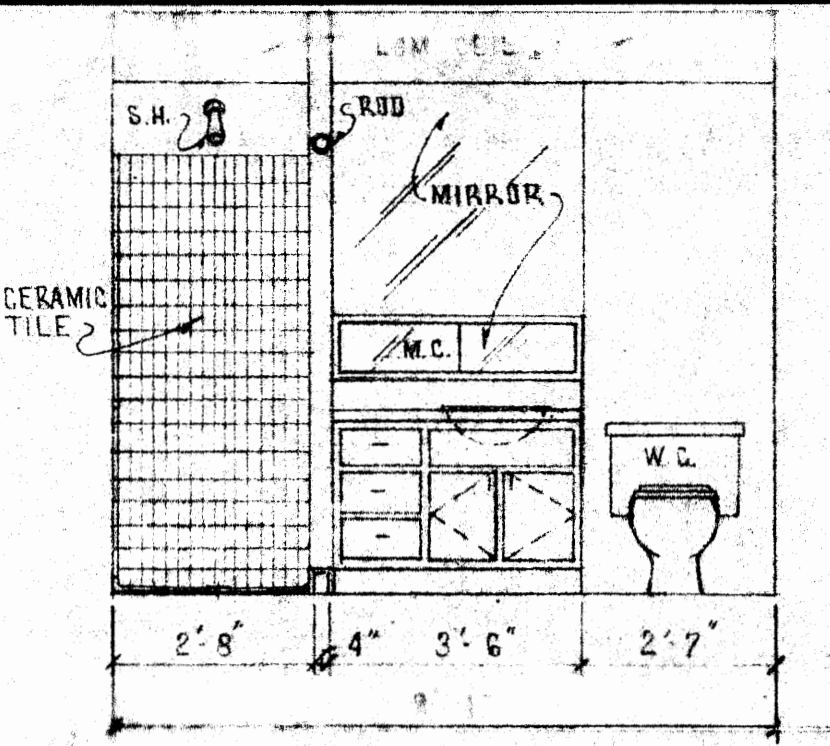


BATHROOM ELEVATIONS

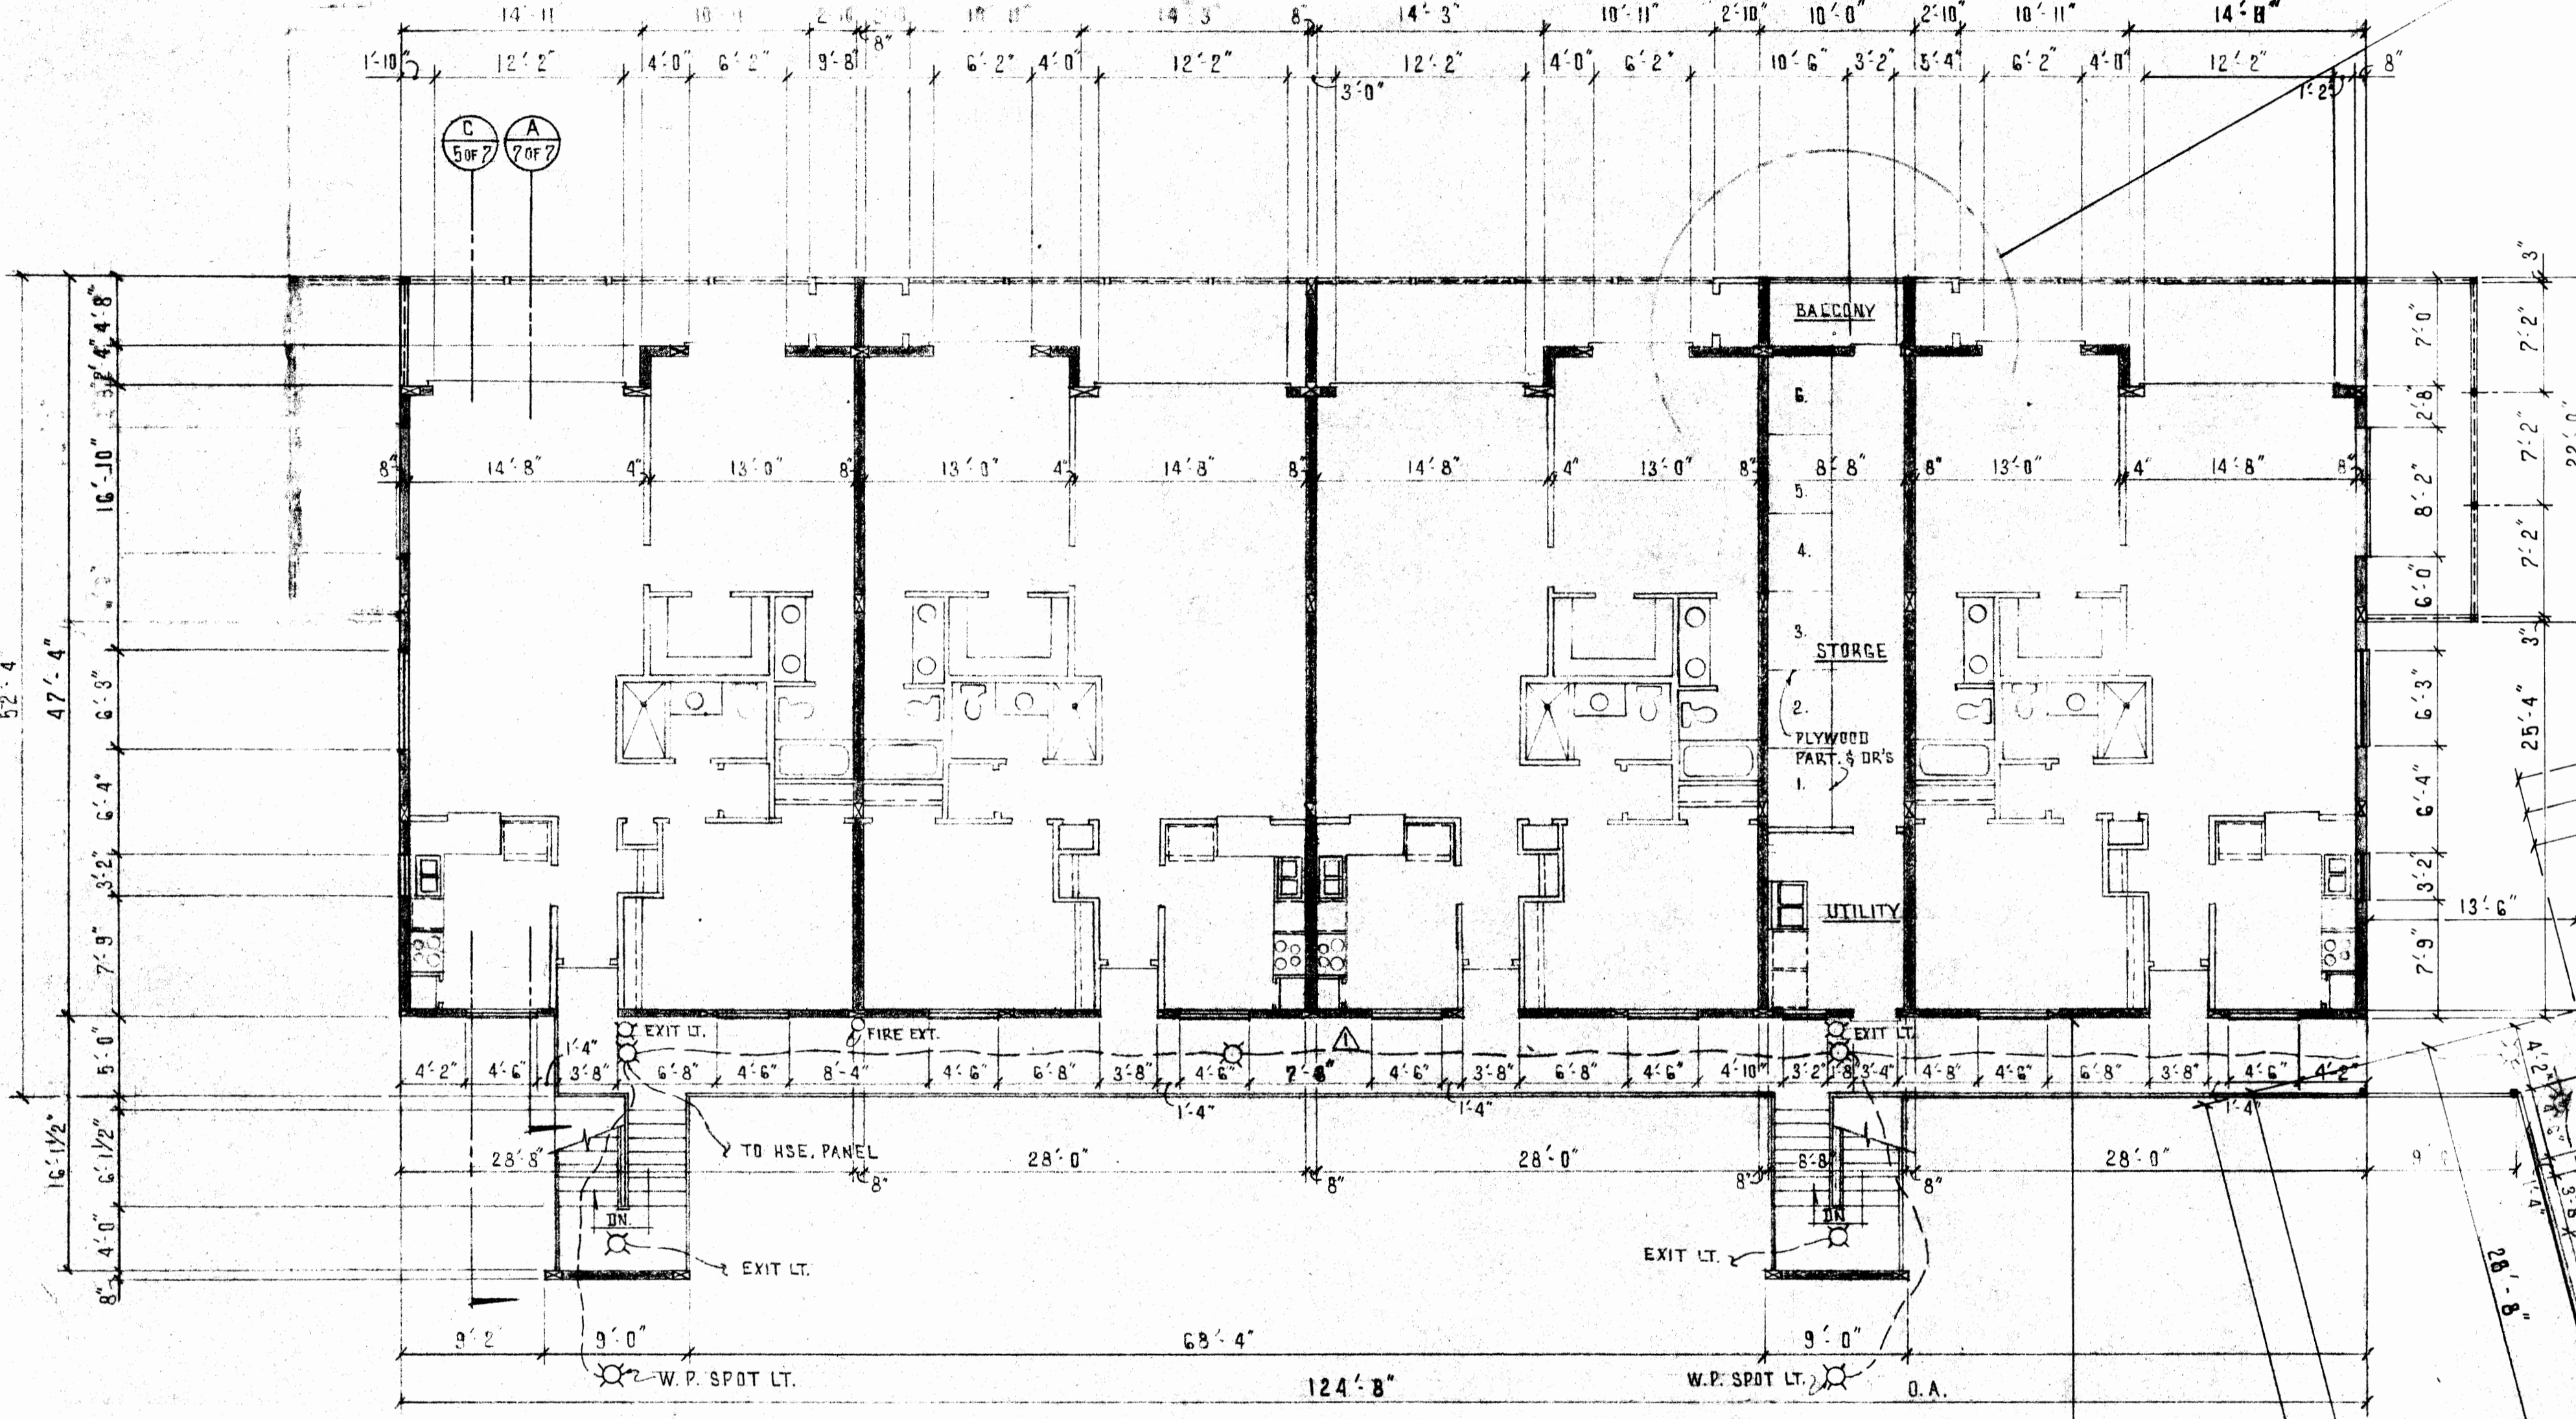


FIRST FLOOR PLAN (AS SHOWN)
SECOND FLOOR PLAN (SIMILAR - SEE DETAILS)
SCALE: 1/8" = 1'-0"

VENT TO OUTSIDE
END UNITS ONLY


ELEVATION A
END APTS.

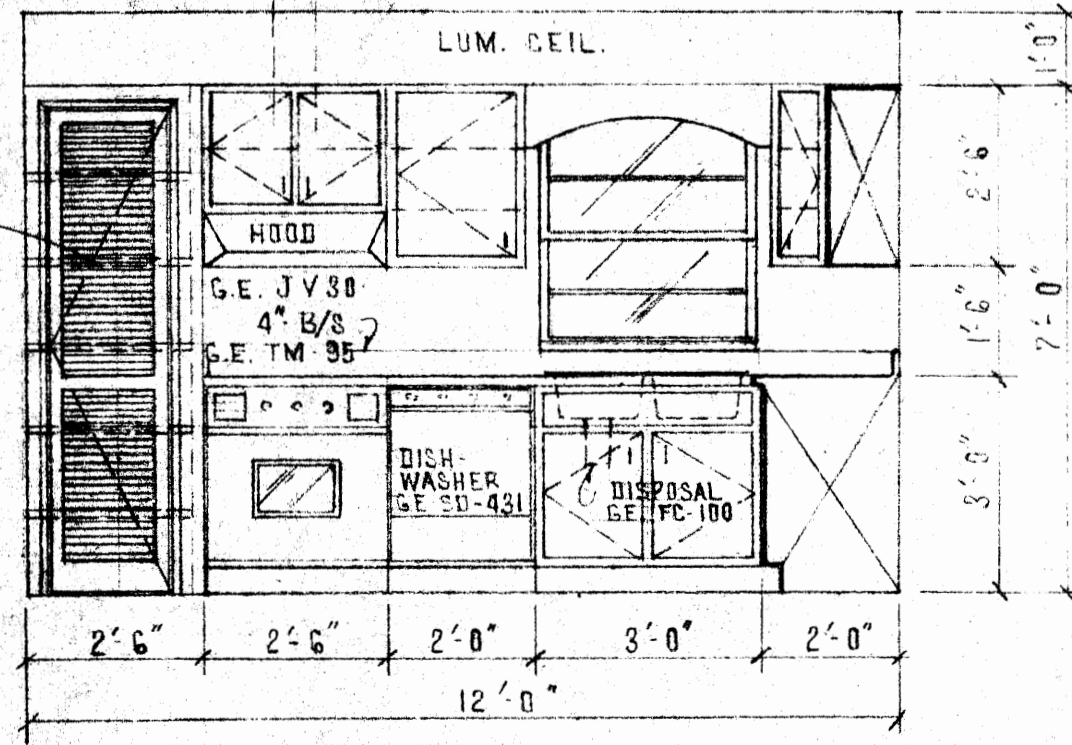

ELEVATION B

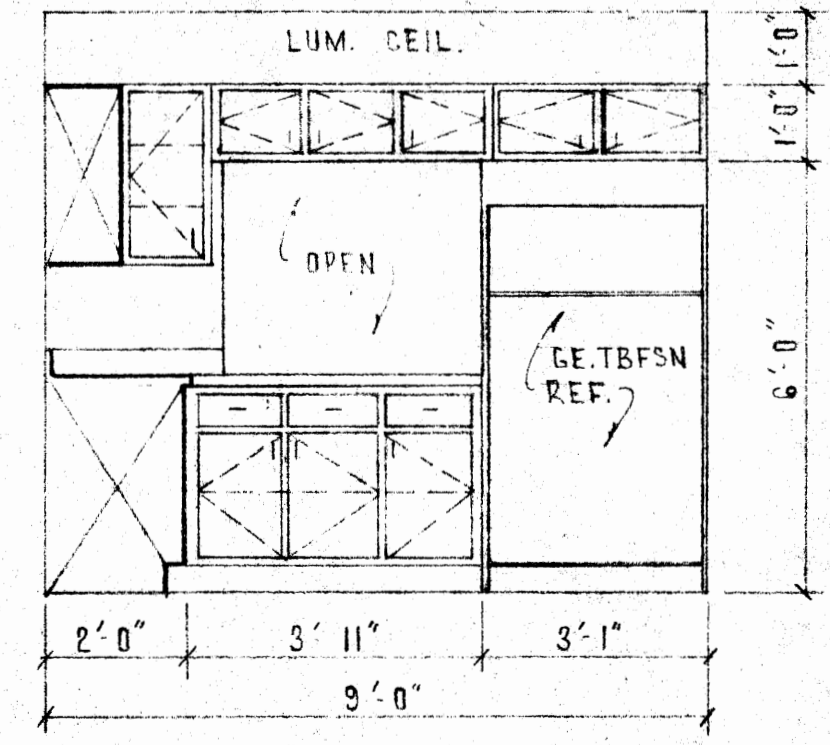


ELEVATION C
INSIDE APTS.

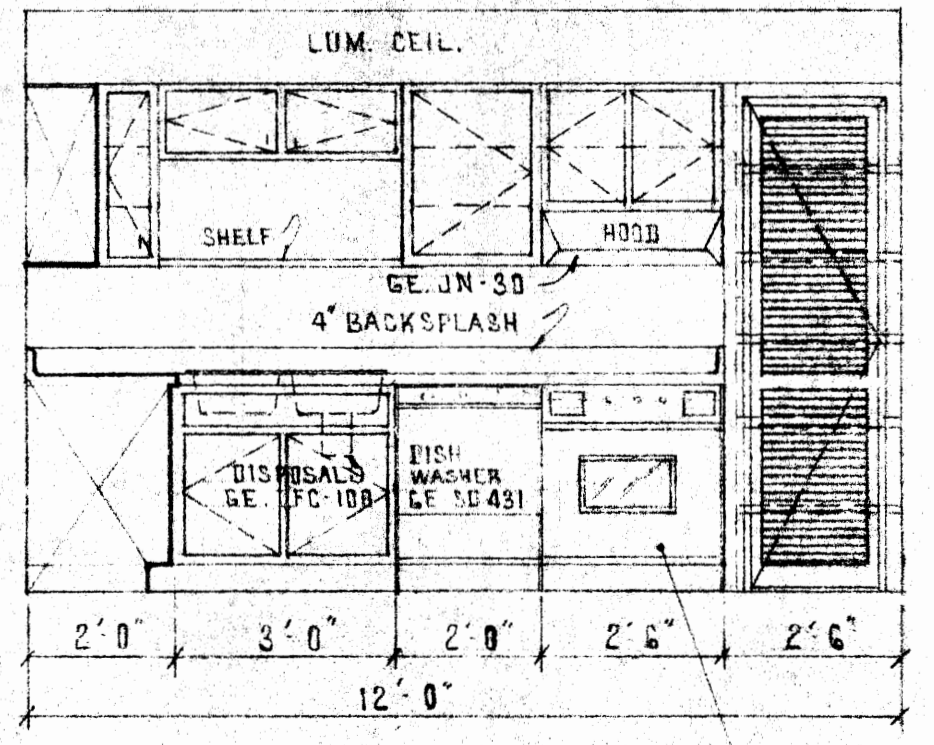

KITCHEN ELEVATIONS


SECOND FLOOR UTILITY,
STORAGE RM. & BALCONY
DETAILS.

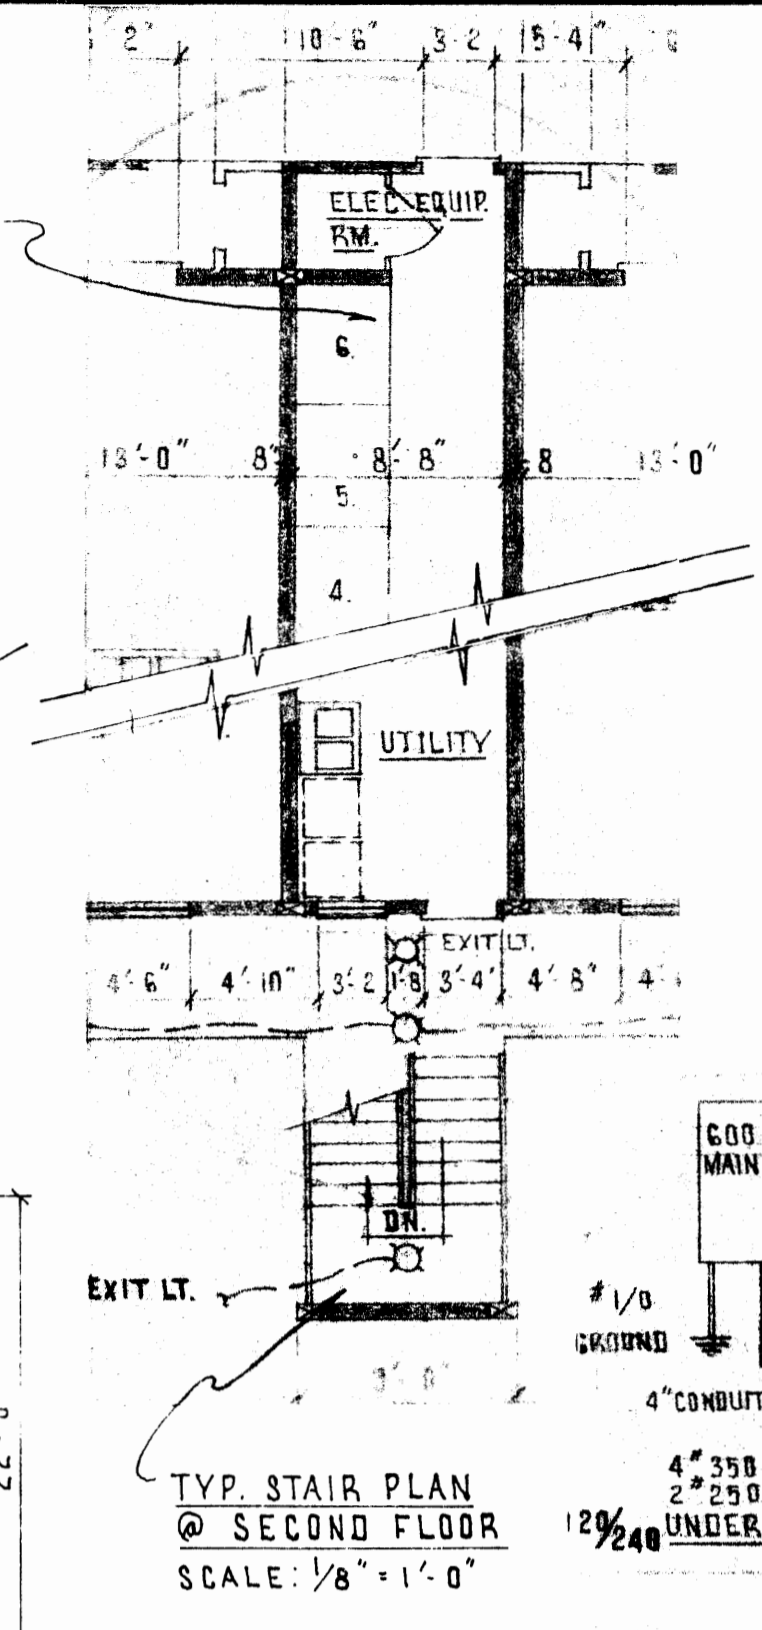

TYP. STAIR PLAN
@ SECOND FLOOR
SCALE: 1/8" = 1'-0"


TYPICAL SERVICE
TO ALL APTS.
1/4\"/>

MAIN DISCONNECT	WIRE SIZES	A/C RANGE
1-30 A	3 #8 THW	A/C RANGE
1-50 A	3 #6 TW	W/H APP.
1-20 A	2 #10 TW	LTG.
3-15 A	2 #14 TW	SPARE
2-15 A	2 #12 TW	

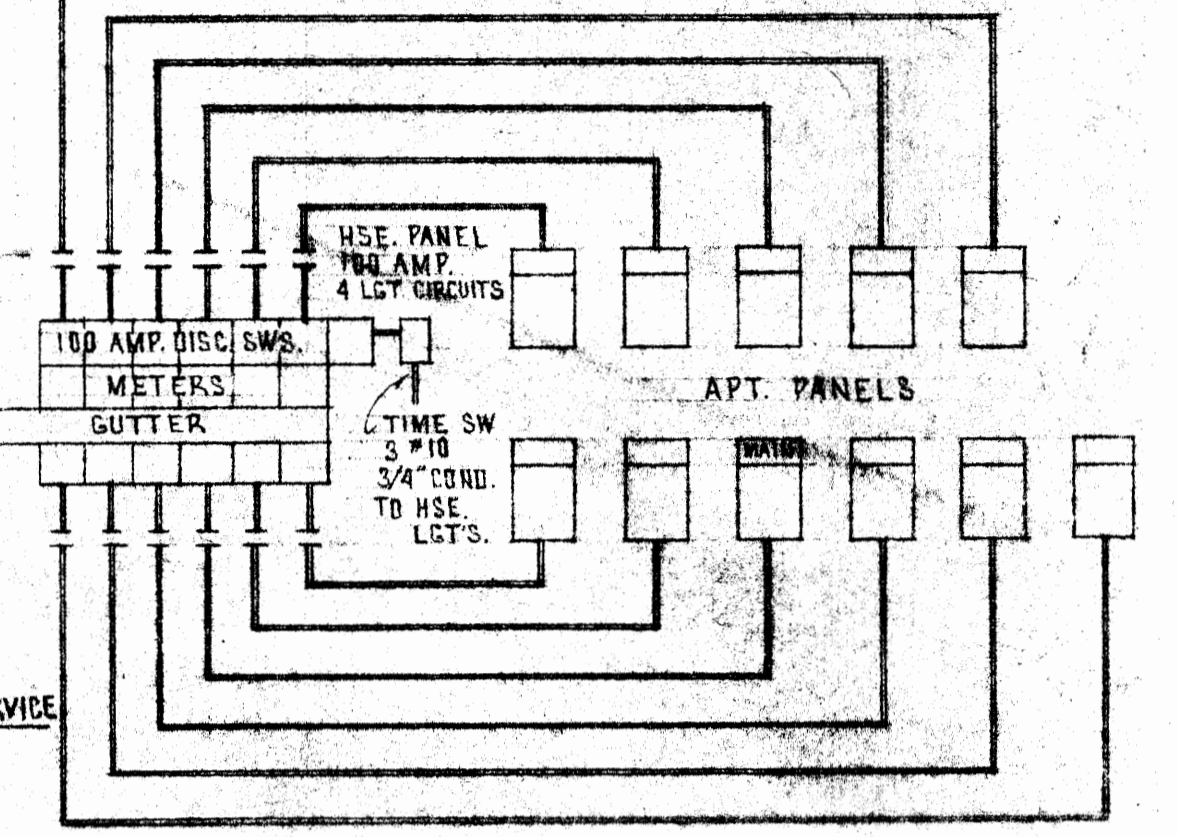

ELECTRICAL RISER

N.T.S.
NOTE: ALL EXTERIOR
EQUIPMENT
SHALL BE W.P.

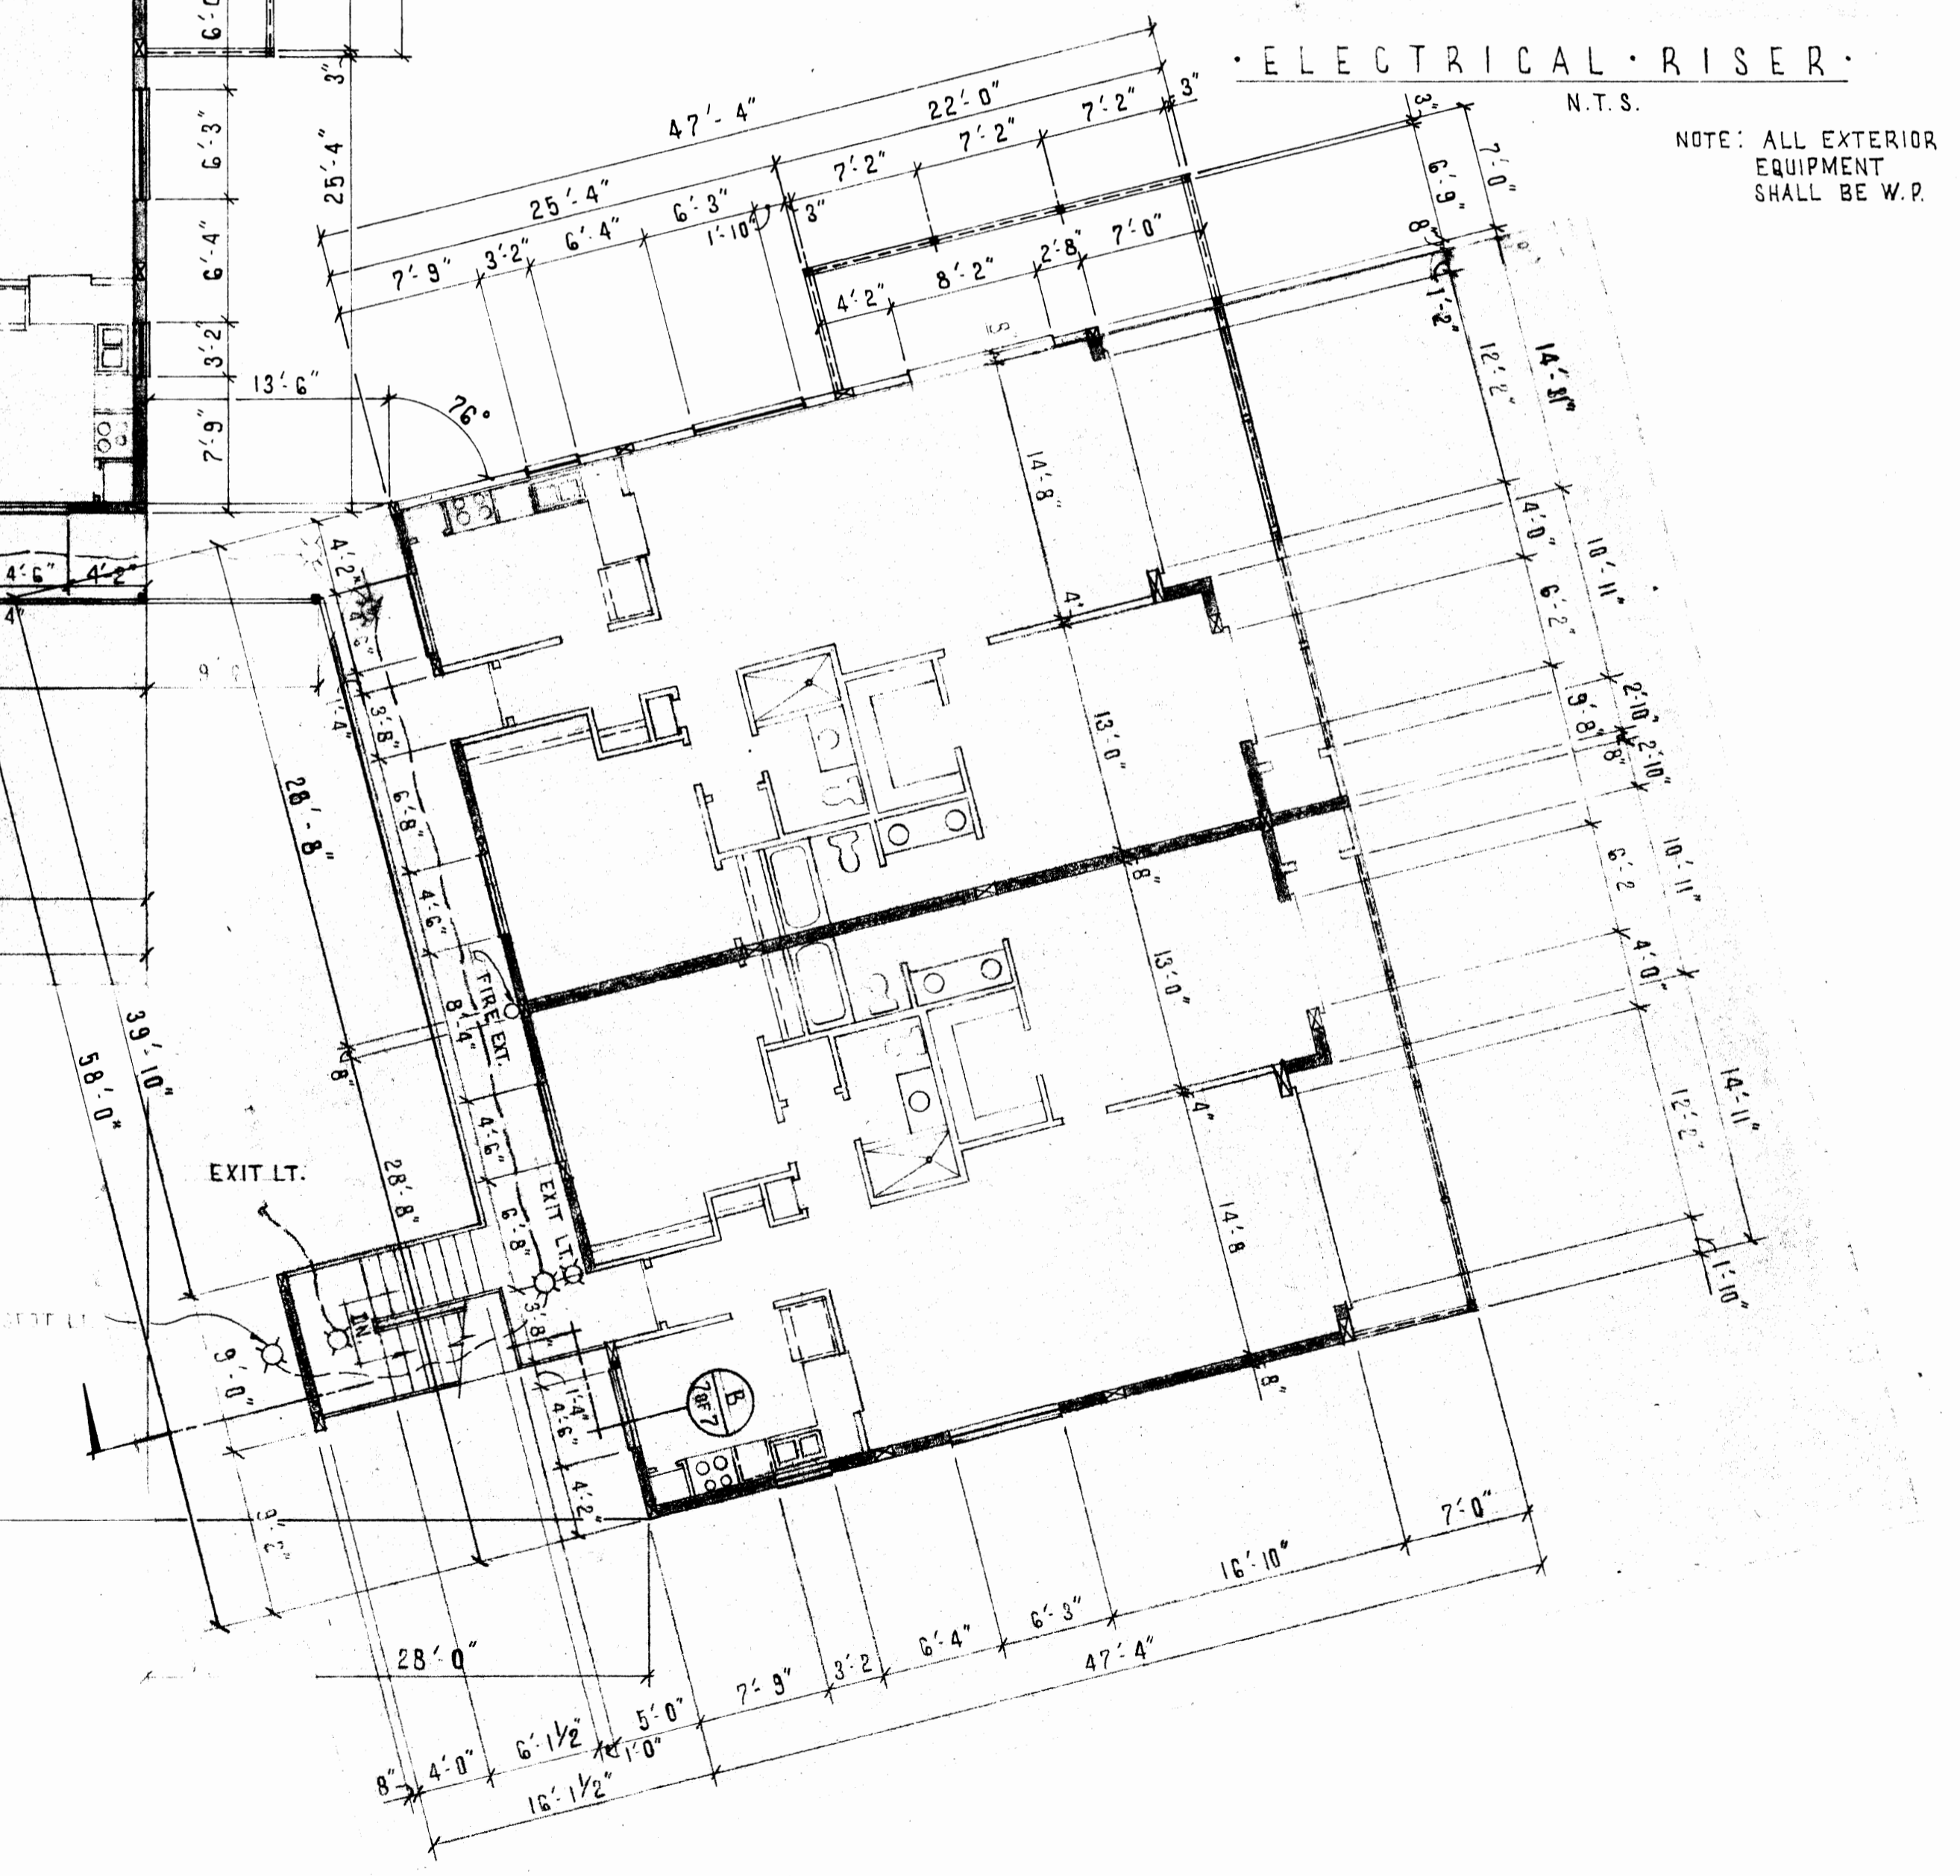

COLLINS AND COMPANY
consulting engineers

2586 FORREST HILL BOULEVARD • WEST PALM BEACH • FLORIDA 33406

WINDJAMMER 12 UNIT CONDO
BUILDING "A" THE STAR OF INDIA
FIRST & SECOND FLOOR PLANS, INTERIOR
ELEVATIONS & ELECTRICAL RISER

revisions
1. 2-2-72 DIM. WA. 8\"/>
2. 2-2-72 DIM. WA. 8\"/>
3. 2-2-72 DIM. WA. 8\"/>
100. 2-2-72 DIM. WA. 8\"/>

designed by
D.L.L.
scale
AS NOTED
date
12-5-72
2 of 7
drawing number
212114